



ALL DIMENSIONS IN MILLIMETRES - DO NOT SCALE

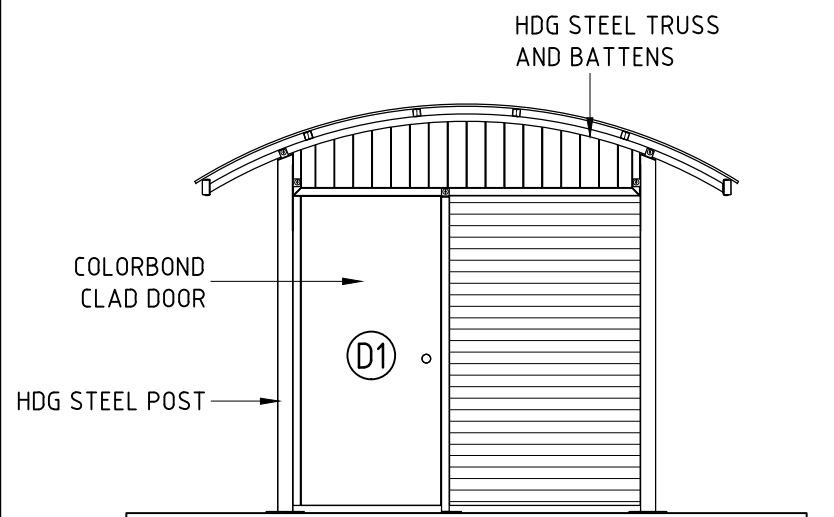

**ELEVATION 1**

SCALE 1:50

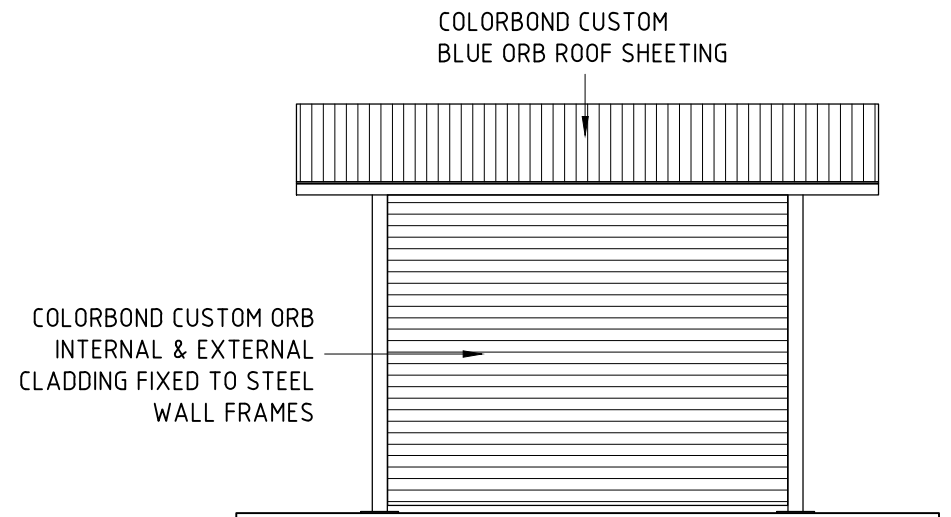

**ELEVATION 2**

SCALE 1:50

**DOOR LEGEND**

D1-2045x925 COLORBOND CLAD DOOR-STEEL FRAME

**LEGEND**

- WD = STAINLESS STEEL DISABLED COMPLIANT PAN
- ID = INDUCT PLASTIC CISTERN
- BL = SS BASIN C/W TORRENS TF0985 SELF CLOSING LEVER TAP
- BTS = BRAILLE TACTILE SIGNAGE
- DR = DISABLED COMPLIANT RAILS
- BR = STAINLESS STEEL COMPLIANT BACK REST
- SH = STAINLESS STEEL SHELF
- CH = COAT HOOK
- TRH = TOILET ROLL HOLDER
- HC = HOSE COCK-VANDAL PROOF KEY TAP W/ HOSE MOUNT


**LEGEND (SUPPLY BY LANDMARK)**

- BTS = BRAILLE TACTILE SIGNAGE
- DR = DISABLED COMPLIANT RAILS
- TRH = TOILET ROLL HOLDER

**LEGEND (SUPPLY BY OTHERS)**

- WD = DISABLED COMPLIANT PAN
- ID = INDUCT CISTERN
- BL = DISABLED COMPLIANT BASIN
- BR = DISABLED COMPLIANT BACK REST
- SH = DISABLED COMPLIANT SHELF
- CH = COAT HOOK
- HC = HOSE COCK

NOTE: IT IS THE RESPONSIBILITY OF THE CLIENT TO ENSURE ALL PLUMBING FIXTURES & ACCESS COMPLIANCE REQUIRED ITEMS NOT SUPPLIED BY LANDMARK MEET THE REQUIREMENTS OF AS14:28.1

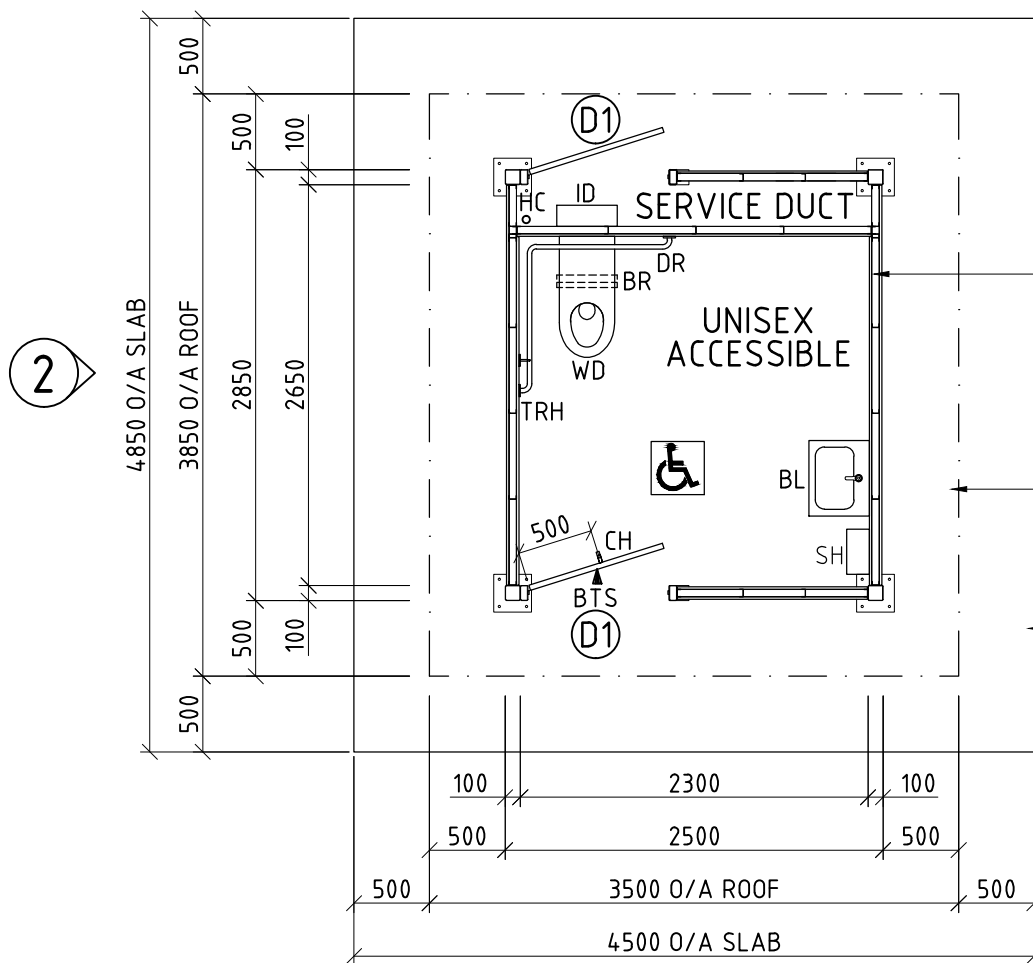

**PLAN**

SCALE 1:50



- ALL WALLS TO 2100 HIGH UNLESS NOTED.
- SIDE WALLS TO CUBICLES TO 2350 HIGH.
- INTERNAL WALL BETWEEN SERVICE DUCT AND CUBICLES TO 2350 HIGH.
- ALL WALLS TO HAVE 50 GAP UNDER.

ROOF LINE OVER

SLAB LINE

**CLIENTS DESIGN APPROVAL**

APPROVED \_\_\_\_\_ DATE: \_\_\_\_\_

REVISION	DATE:	DRAWN BY:
6		
5		
4		
3		
2		
1		

DATE:	DRAWN BY:

© LANDMARK PRODUCTS LIMITED  
 THIS DOCUMENT IS AND SHALL REMAIN THE PROPERTY OF LANDMARK PRODUCTS LIMITED. UNAUTHORISED USE OF THIS DOCUMENT IN ANY FORM IS PROHIBITED.

CHECKED BY: \_\_\_\_\_ DATE: \_\_\_\_\_

**Landmark**  
 Enhancing Open Space Environments

Landmark Products Limited. PH: 1300 768 230  
 A.B.N. 99 112 000 843 FAX: 1300 768 260  
 55-57 Kabi Circuit, Deception Bay  
 P.O. Box 603, Deception Bay www.landmarkpro.com.au  
 Queensland 4508 landmark@landmarkpro.com.au

CLIENT NAME	PROJECT No.	PAGE
	<b>K9704</b>	<b>A3</b>
PROJECT	DATE:	DRAWN
<b>PROPOSED AMENITIES BUILDING K9704 "PARKLAND" 1D (CURVED) RESTROOM BOLT DOWN TO TOP OF SLAB FIXING</b>	<b>05-06-2014</b>	<b>JEO</b>
DRAWING TITLE	DRAWING No.	SCALE
<b>BA - PLAN AND ELEVATIONS</b>	<b>K9704 BD</b>	<b>NOTED</b>
	SHEET No.	REV.
	<b>101</b>	<b>0</b>